




LUMINAIRE SCHEDULE									
Symbol	Label	Qty	Catalog Number	Description	Lamp	File	Lumens	LLF	Watts
□	S1	7	DSX0 LED 40C 1000 50K TFTM MVOLT HS	DSX0 LED WITH (2) 20 LED LIGHT ENGINE, TYPE TFTM OPTIC, 5000K @ 1000mA WITH HOUSE SIDE SHIELD	LED	DSX0_LED_40 C_1000_50K_T FTM_MVOLT_ HS.is	Absolute	0.91	138
△	S2	1	Lithonia Ltg # DSX0 LED 40C 1000 50K T5W MVOLT RPA (Mounted 20' a.t.g. on pole)	DSX0 LED WITH (2) 20 LED LIGHT ENGINE, TYPE T5W OPTIC, 5000K @ 1000mA	LED	DSX0_LED_40 C_1000_50K_T 5W_MVOLT.is	Absolute	0.91	138

STATISTICS						
Description	Symbol	Avg	Max	Min	Max/Min	Avg/Min
Parking Area	+	1.8 fc	4.5 fc	0.5 fc	9.0:1	3.6:1

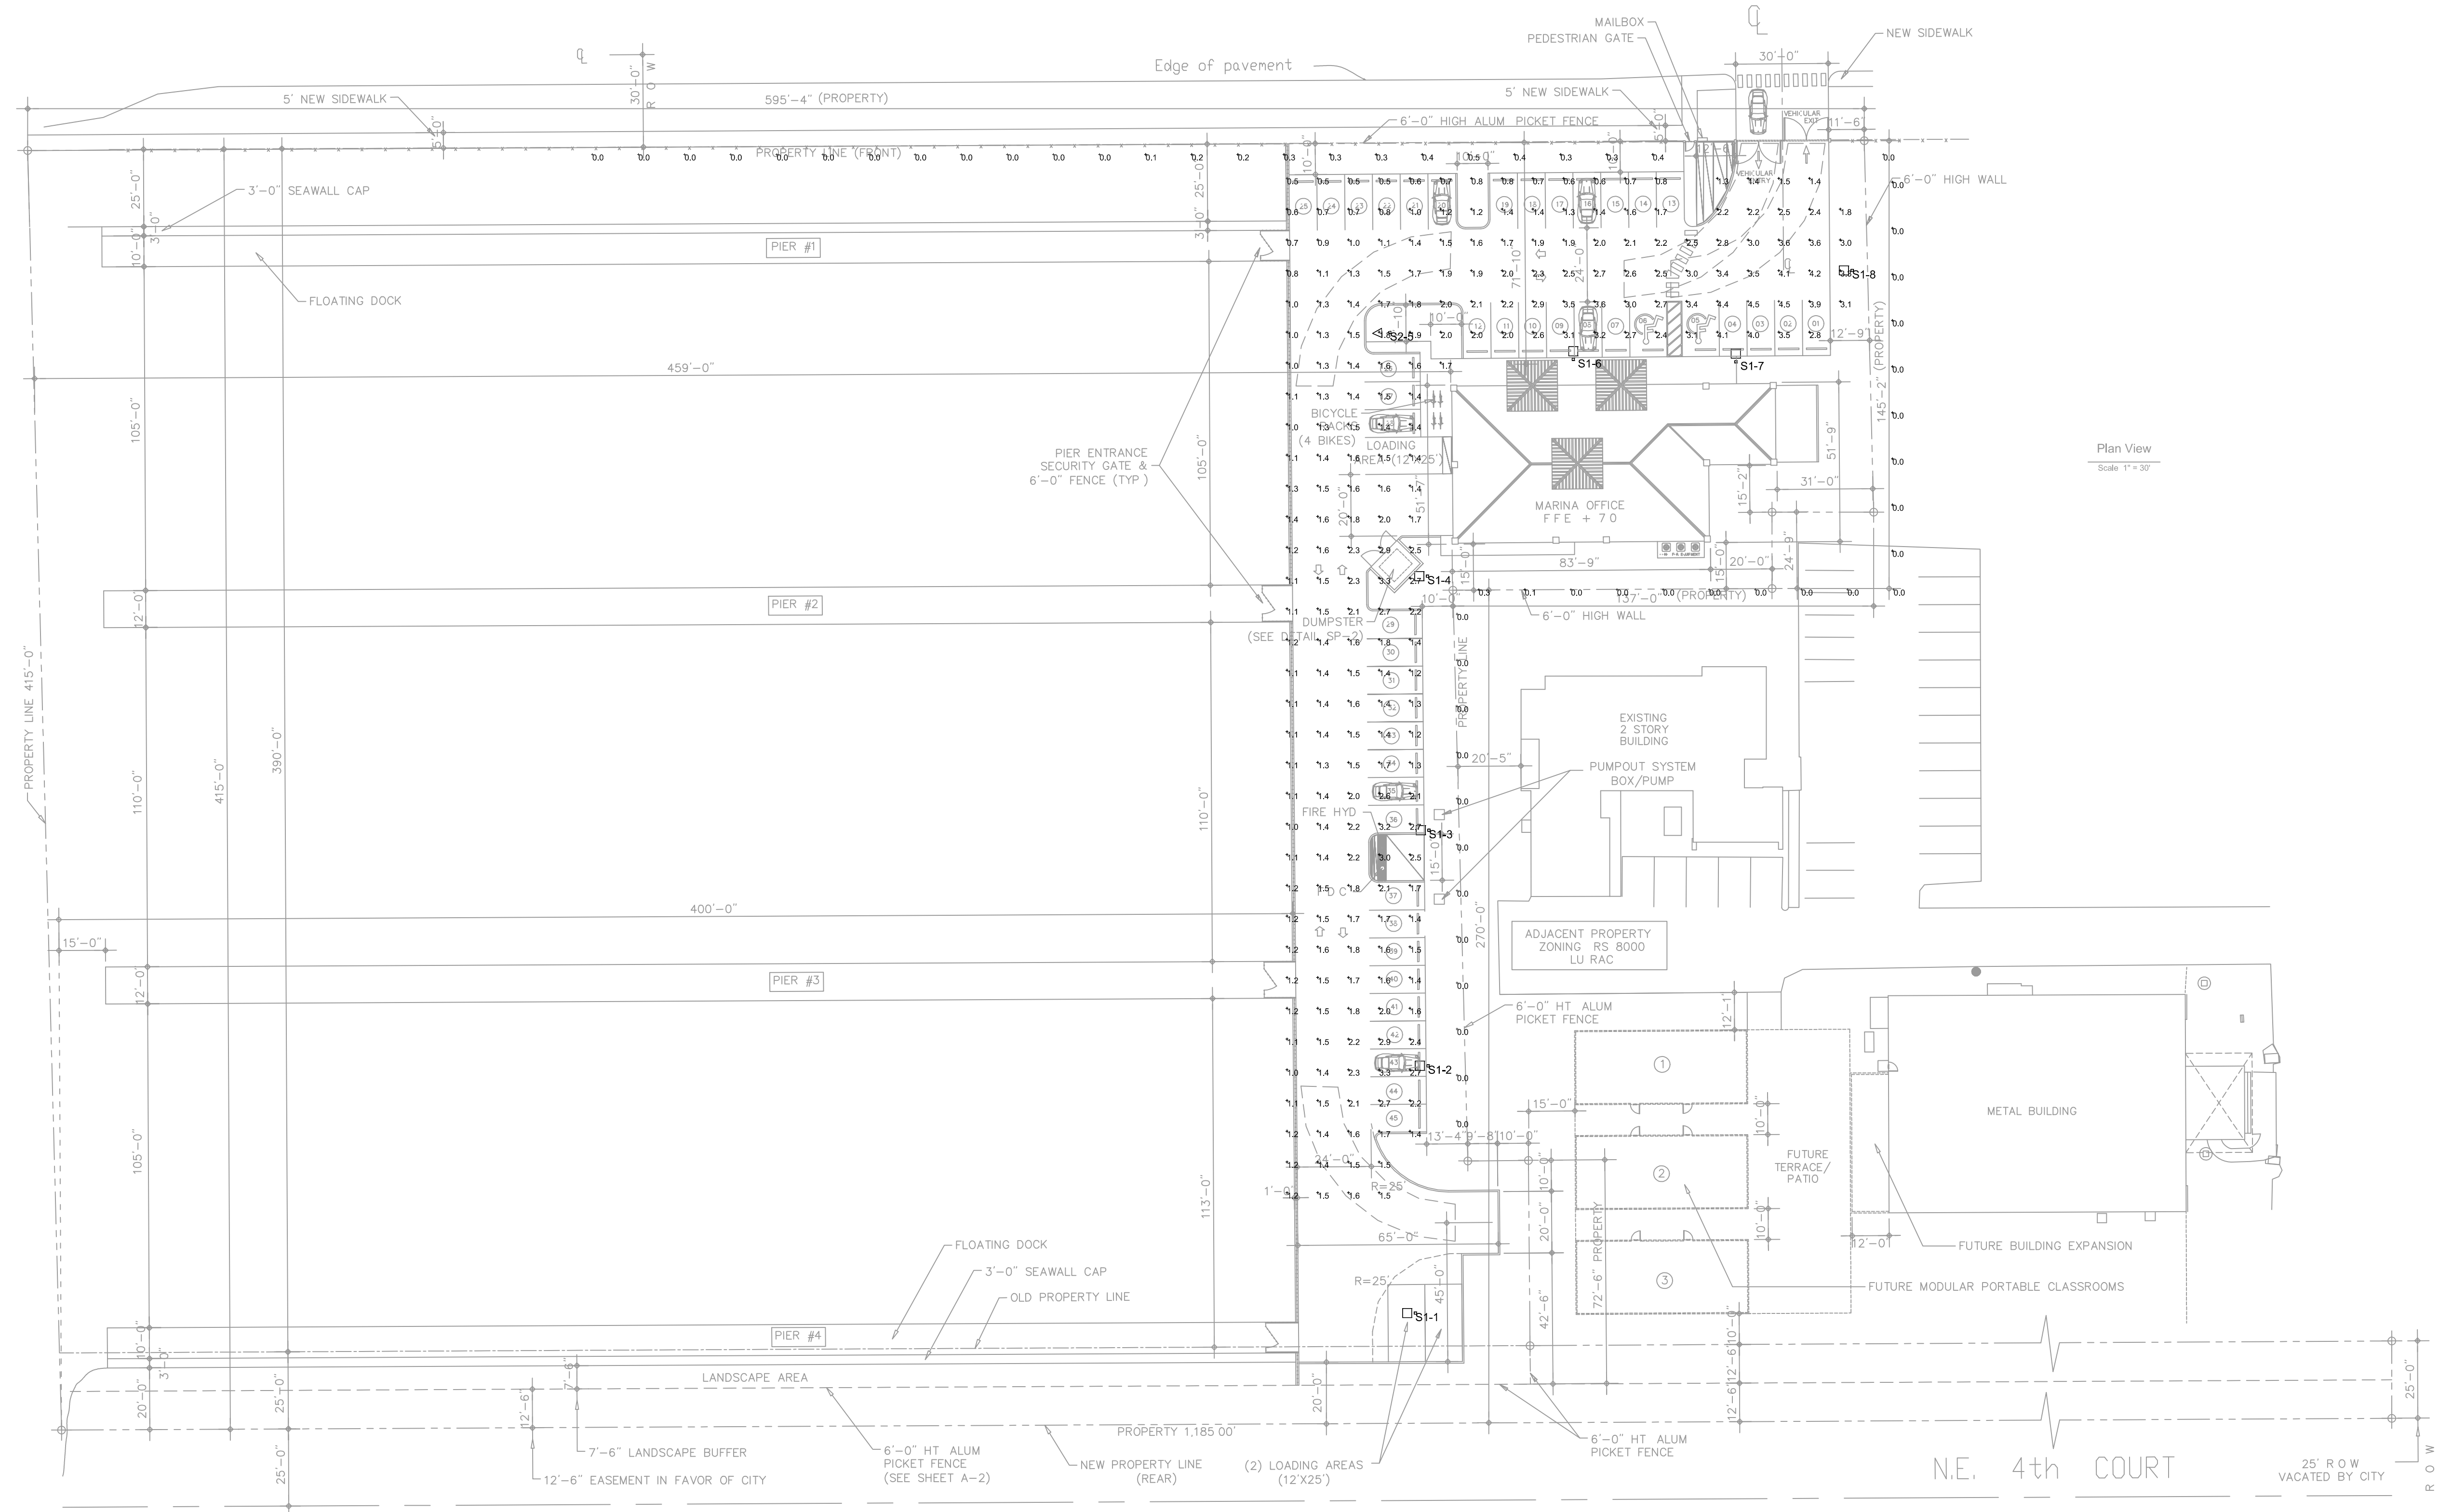

PHOTOMETRIC PLAN

SCALE: 1"=30'

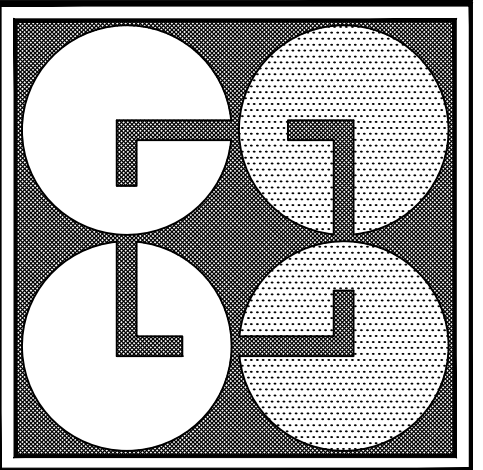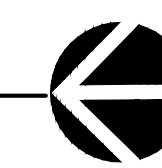

GUTIERREZ & LOZANO ARCHITECTS

2830 W. STATE ROAD 84, SUITE 117
FT. LAUDERDALE, FL. 33312
PHONE: (954) 321-3442
FAX: (954) 321-3864
WWW.GUTIERREZLOZANO.COM

REVISIONS	
△	DRC I COMMENTS 6-04-15
△	DRC II COMMENTS 6-29-15

MANUEL GUTIERREZ
STATE OF FLA. REG. No. 8253

SEAL

CARLOS LOZANO
STATE OF FLA. REG. No. 0014722

PROPOSED SITE PLAN FOR:

DANIA BEACH MEGAPORT

AT:
441 NE 2ND ST.
DANIA BEACH, FL 33004

SHEET TITLE :

PHOTOMETRIC PLAN

JOB No.:

DATE: 04/07/15

SHEET

PH-1

OF

EDELMAN DANIA